


plumbing  
schedules & details

project no.:	05067
scale:	no scale
date:	september 15, 2005
drawn:	me

deli towne usa expansion  
3610 lakeside drive  
reno, nevada

project

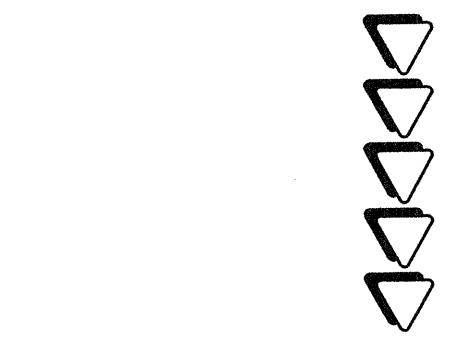

revisions

© 2005 Aspen Architecture

registration

3748 lakeside drive  
suite 101  
reno, nv 89509  
775.324.6811  
fax 770.0110


ASPEN ENGINEERING  
6480 South Dickerson Blvd. Suite 200  
Reno, Nevada 89509

**NOTICE TO BIDDERS**


BIDS ARE TO BE BASED ON EXACT ITEMS (MANUFACTURER AND MODEL NUMBER) SPECIFIED IN THESE SPECIFICATIONS TO SUBMITTAL OTHER ITEMS HAS BEEN GUARANTEED BY THE ENGINEER. THE CONTRACTOR ASSUMES ALL RISK THAT ALTERNATE EQUIPMENT MAY BE REJECTED DURING THE SUBMITTAL PROCESS. THE CONTRACTOR MAY BE REQUIRED TO PROVIDE & INSTALL THE EXACT EQUIPMENT SHOWN ON THIS DRAWING. VALUE ENGINEERING ISSUES WILL BE ADDRESSED AFTER THE BID PROCESS IS COMPLETE.

**PLUMBING LEGEND**


99	WASTE PIPING	---
GI	GRADE INTERCEPTOR PIPING	---
V	VENT PIPING	---
TU	TEMPERED WATER PIPING	---
CW	COLD WATER PIPING	---
HU	HOT WATER PIPING	---
HUR	HOT WATER RETURN PIPING	---
RD	ROOF DRAIN PIPING	---
ORD	OVERFLOW ROOF DRAIN PIPING	---
G	GAS PIPING	---
C	CONDENSATE DRAIN PIPING	---
FS	FIRE SERVICE PIPING	---
FD	FIRE DOWN	---
FOC	POINT OF CONNECTION	---
VTR	VENT THRU ROOF	---
COTG	CLEANOUT TO GRADE	---
FCO	FLOOR CLEANOUT	---
WCO	WALL CLEANOUT	---
SOV	SHUT OFF VALVE	---
CV	CHECK VALVE	---
UNION	UNION	---
TRM	THERMOMETER	---
"PTES PLUG"	"PTES PLUG"	---
BOILER DRAIN	BOILER DRAIN	---
BALANCING VALVE	BALANCING VALVE	---
FLEX CONNECTOR	FLEX CONNECTOR	---
AFG	ABOVE FINISHED GRADE	---
AEF	ABOVE FINISHED FLOOR	---
(E)	EXISTING	---
(N)	NEW	---

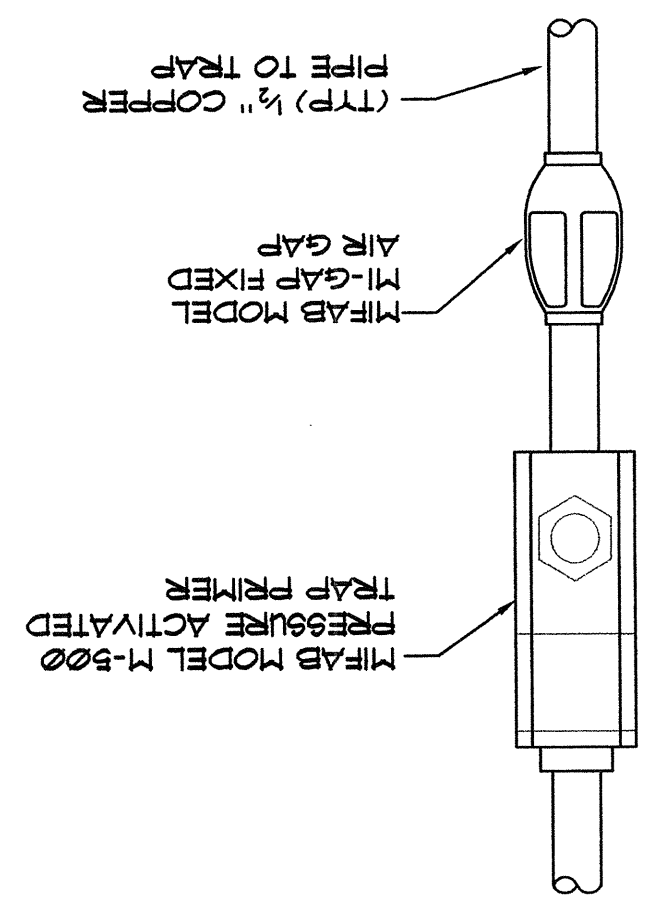

**TRAP PRIMER DETAIL**  
SCALE: NOT TO SCALE

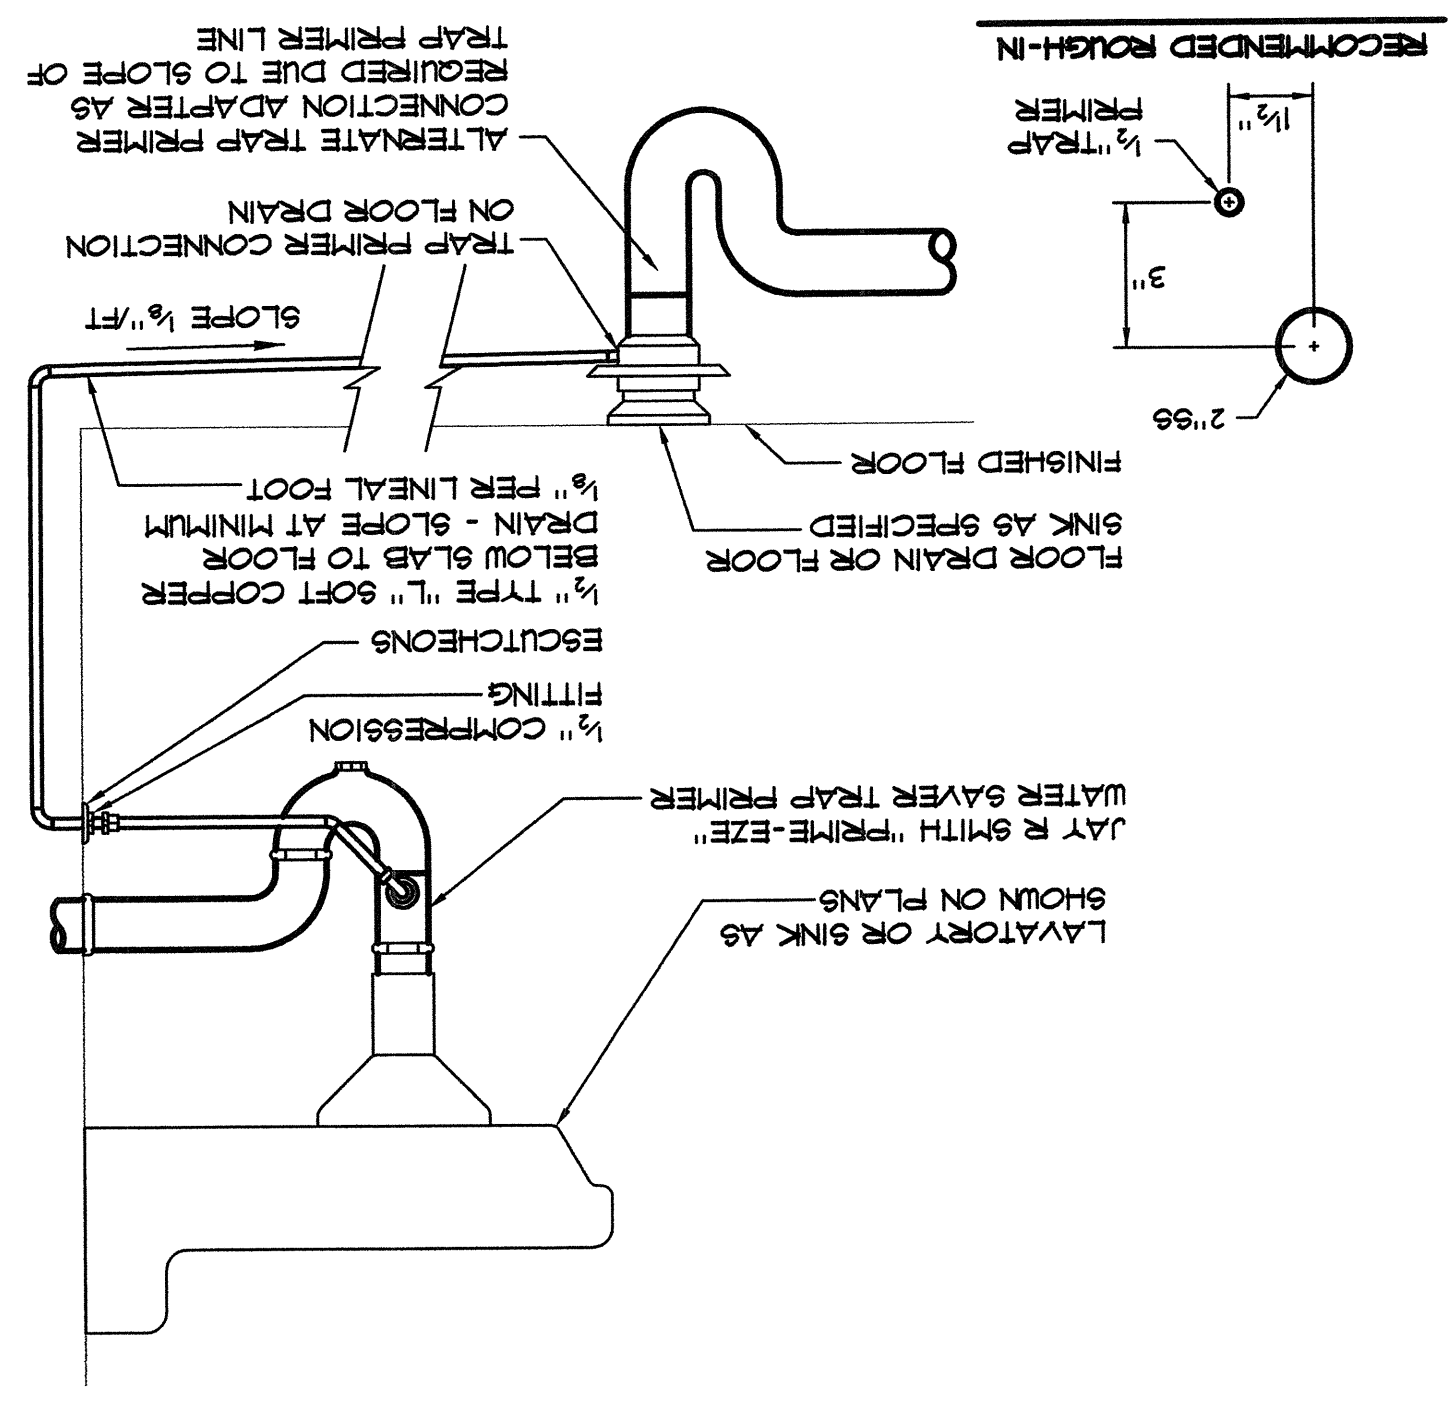

**ROOFTOP GAS OR VENT PIPING DETAIL**  
SCALE: NOT TO SCALE

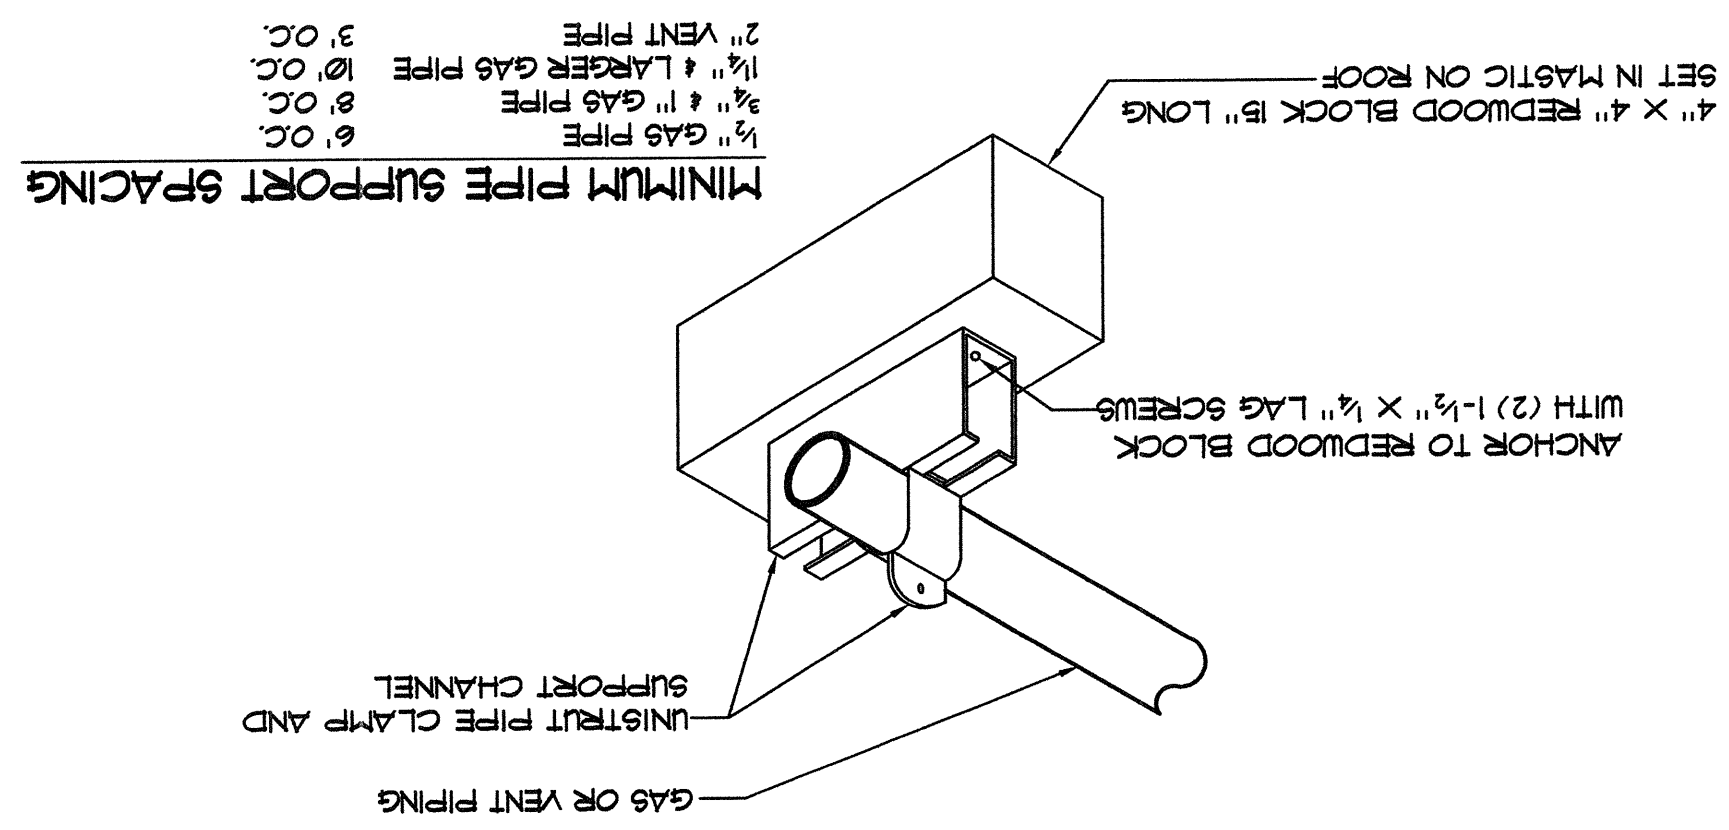

**PLUMBING FIXTURE SCHEDULE**

SYMBOL	DESCRIPTION	MAKE & MODEL NO.	CONNECTIONS		FLOWRATE	ACCESSORIES		
			CW	HU			99	V
UC	VITREOUS CHINA ELONGATED BOWL "CHAMPION" MODEL 202212	AMERICAN STANDARD	1/2"	-	4"	2"	16 GPF	OPEN FRONT SEAT & ALL SUPPLIES
SHR	FIBERGLASS THREE PIECE SHOWER UNIT	FLORESTONE MODEL 3PC-30-60H	1/2"	1/2"	2"	1/2"	20 GPM	INCLUDES MIXING VALVE AND HANDHELD SHOWER HEAD
AV	VITREOUS CHINA COUNTERTOP MOUNTED LAVATORY	"AFFINITY" MODEL 3420A03	1/2"	1/2"	2"	1/2"	20 GPM	MODEL 202010 LEVER HANDLE FAUCET SET. SPEEDWAY, TRAP, & ALL SUPPLIES. PROVIDE FLUMBEREX MODEL 2333 INSULATION KIT ON ALL EXPOSED PIPING UNDER SINK
FD	STAINLESS STEEL FLOOR DRAIN	MIFAB F1022-6-3	1/2"	-	2"	1/2"	-	1/2" TRAP PRIMER CONNECTION
FS	CAST IRON FLOOR SINK - 2'x2'	ZURN MODEL Z-1910	-	-	2"	1/2"	-	1/2" GRATE
FS	CAST IRON FLOOR SINK - 12'x12"	ZURN MODEL Z-1922	-	-	3"	1/2"	-	1/2" GRATE

